


NATURAL GAS UTILITY SCHEDULE		
EQUIPMENT DESCRIPTION	TAG	HEATING INPUT (KW)
CONDENSING BOILER	B-1	733
CONDENSING BOILER	B-2	733
TOTAL:		1466

1. GAS REGULATING VALVE TO REGULATE GAS PRESSURE TO 1.75-3.50kPa (7-14" WC)



ISSUED FOR

1	2021-06-25	INTERNAL REVIEW
2	2021-07-23	100% DESIGN DEVELOPMENT QA
3	2021-08-06	SITE PLAN APPROVAL

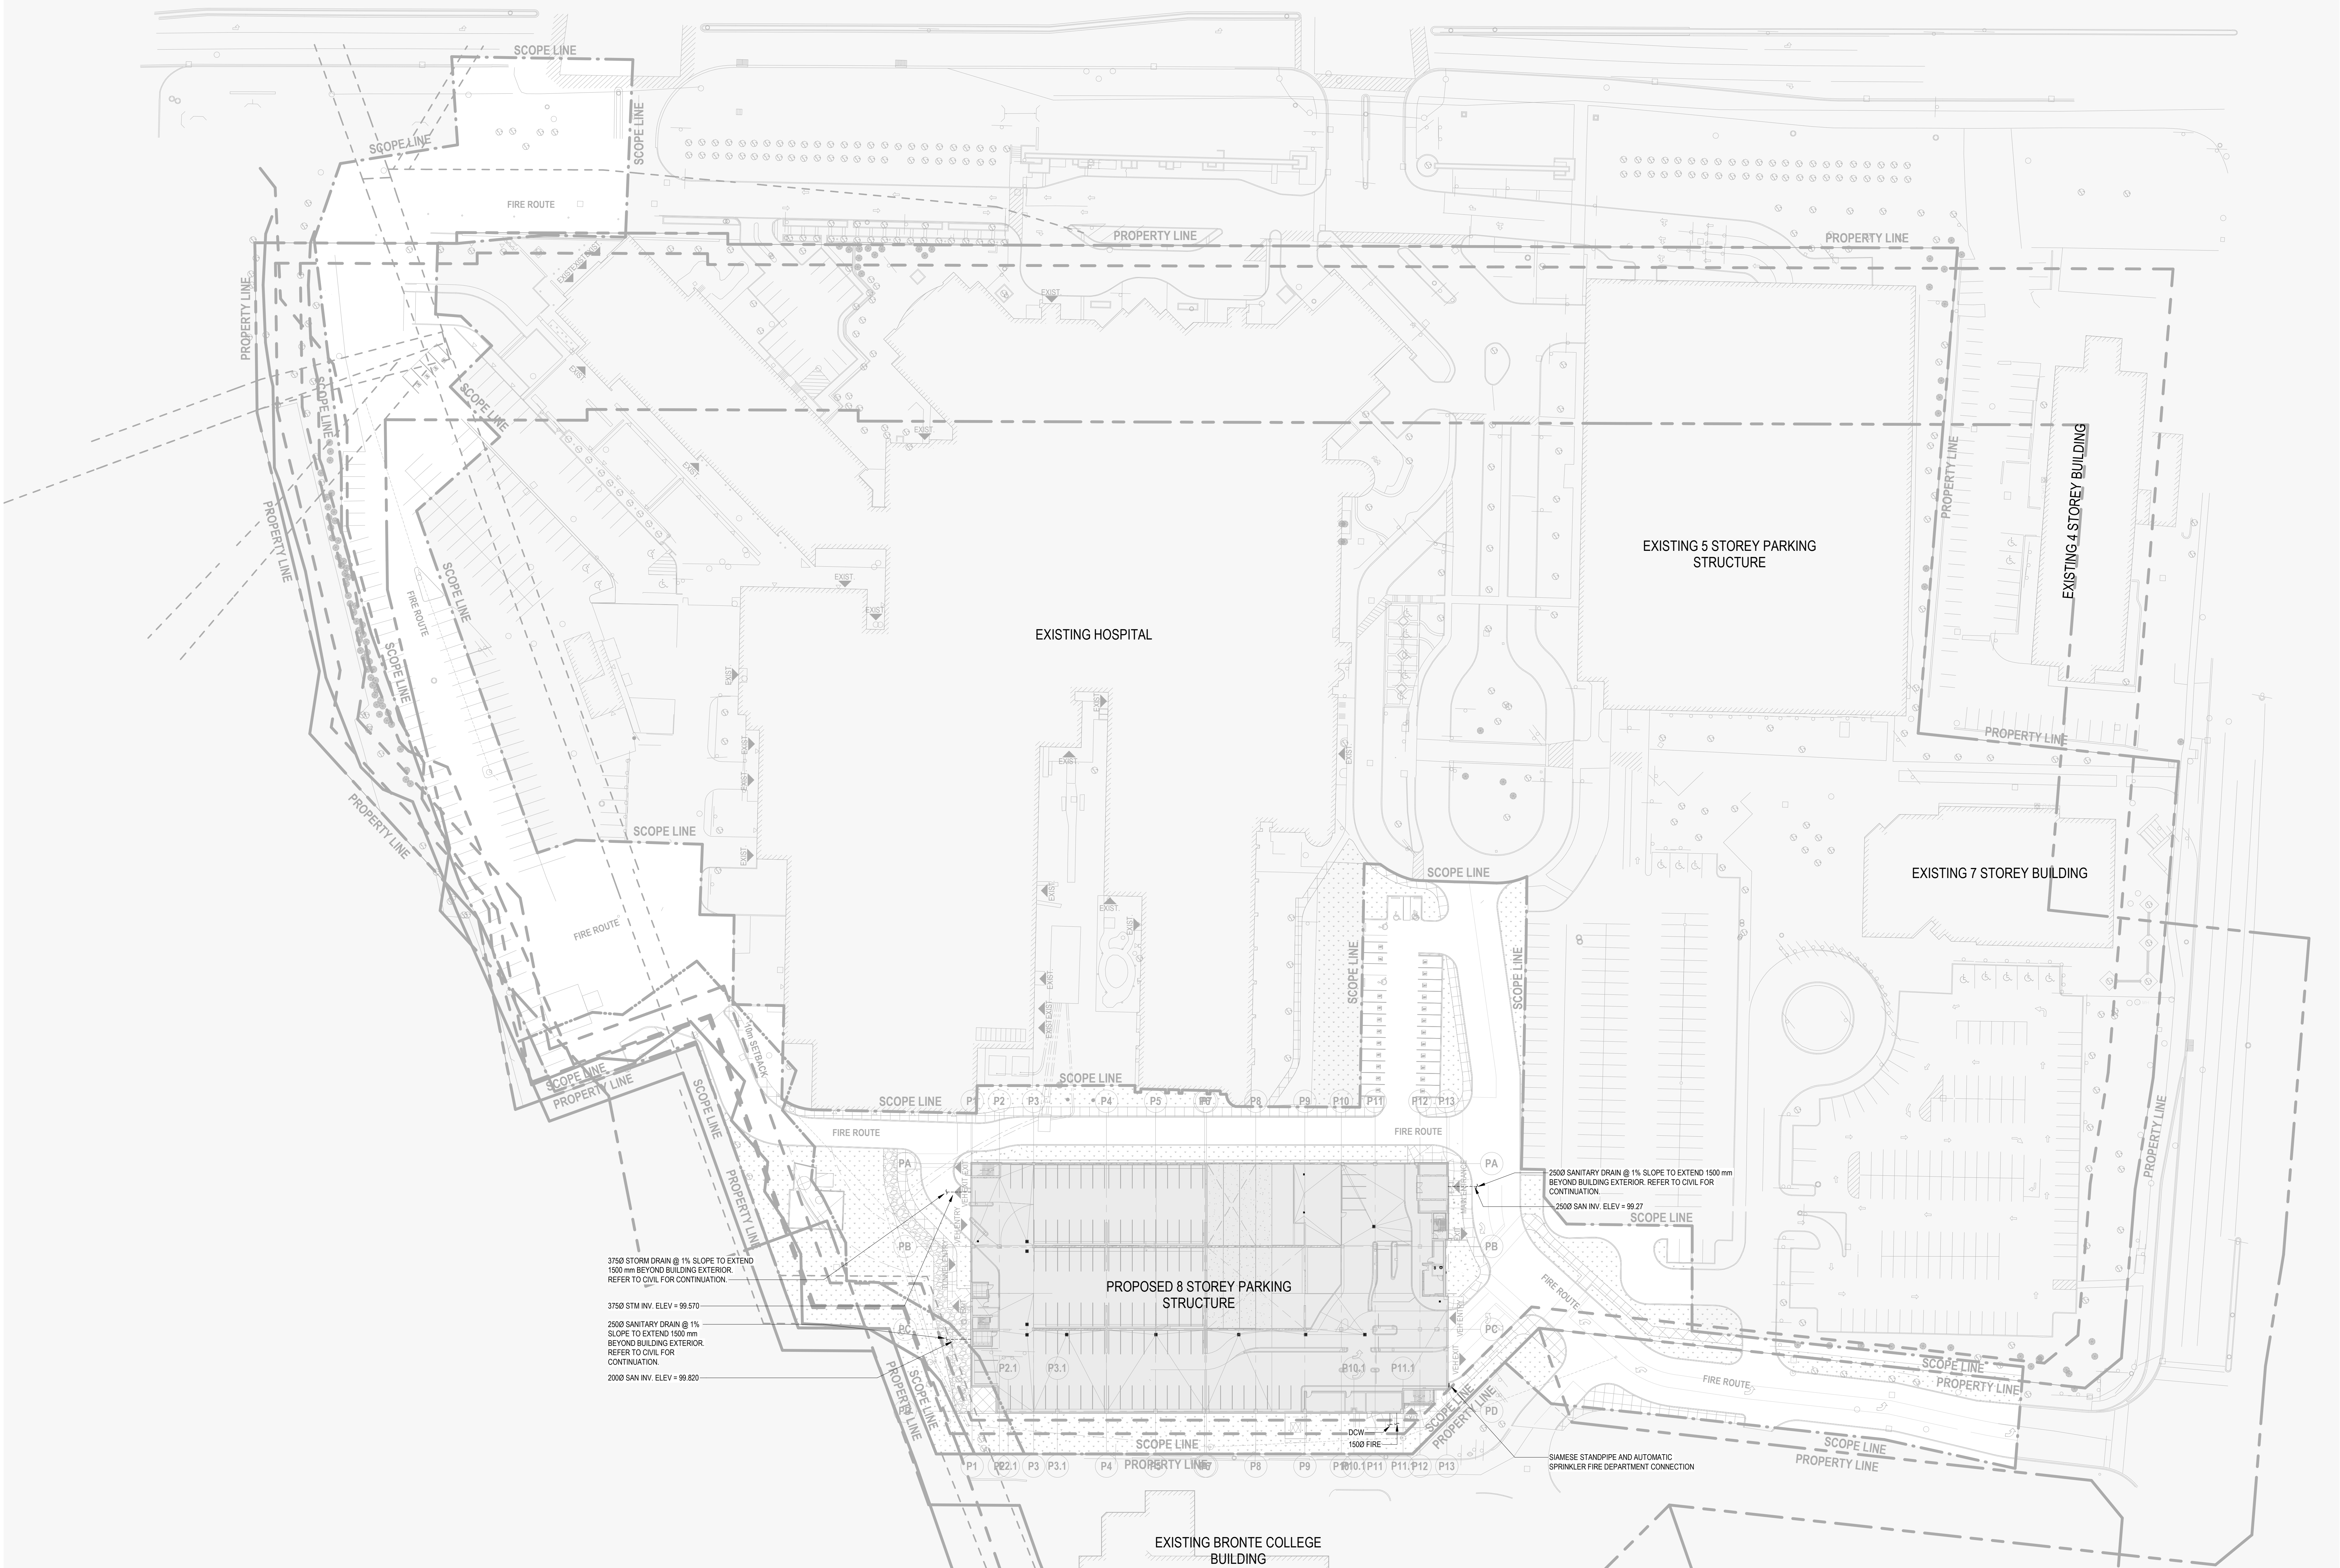

3750 STORM DRAIN @ 1% SLOPE TO EXTEND 1500 mm BEYOND BUILDING EXTERIOR. REFER TO CIVIL FOR CONTINUATION.

3750 STM INV. ELEV = 99.570

2500 SANITARY DRAIN @ 1% SLOPE TO EXTEND 1500 mm BEYOND BUILDING EXTERIOR. REFER TO CIVIL FOR CONTINUATION.

2500 SAN INV. ELEV = 99.820

2500 SANITARY DRAIN @ 1% SLOPE TO EXTEND 1500 mm BEYOND BUILDING EXTERIOR. REFER TO CIVIL FOR CONTINUATION.

2500 SAN INV. ELEV = 99.27

METRIC
THIS DRAWING IS COPYRIGHTED AND MUST NOT BE REPRODUCED, OR REVISED WITHOUT WRITTEN PERMISSION. ALL DIMENSIONS ARE IN MILLIMETERS UNLESS OTHERWISE NOTED. VERIFY DIMENSIONS. DO NOT SCALE THIS DRAWING.

REPORT INCONSISTENCIES AND OMISSIONS TO THE CONSULTANT FOR CLARIFICATION BEFORE COMMENCING WITH THE WORK. DEVIATIONS FROM THE CONTRACT DOCUMENTS WITHOUT WRITTEN APPROVAL FROM THE CONSULTANT ARE SUBJECT TO CORRECTION AT THE CONTRACTOR'S EXPENSE.

CLIENT
TRILLIUM HEALTH PARTNERS
150 BURNHAMTHORPE AVE. TORONTO, ON M9C 1A5
TEL: (416) 299-8971 WEBSITE: trilliumhealthpartners.ca

CONSTRUCTION MANAGER
KENADAN CONTRACTING LTD.
7380 DERRICKST DRIVE MISSISSAUGA, ON L5W 0G5
TEL: (905) 890-0900 WEBSITE: www.kenadan.com/

ARCHITECT & PRIME CONSULTANT
DIALOG
55 JOHN STREET, SUITE 500 TORONTO, ON M5V 3G8
TEL: (416) 966-0220 WEBSITE: dialogdesign.ca

STRUCTURAL ENGINEER
DIALOG

MECHANICAL ENGINEER
DIALOG

ELECTRICAL ENGINEER
DIALOG

LANDSCAPE ARCHITECT
DIALOG

CIVIL ENGINEER
MTE CONSULTANTS INC.
1018 SUTTON DRIVE, UNIT A BURLINGTON, ON L7R 1B8
TEL: (905) 639-2562 WEBSITE: mte85.com

SECURITY
THE ATIAN GROUP INC.
298-680 WOODWARD DRIVE OTTAWA, ON K2C 3R7
TEL: (613) 617-0908 WEBSITE: theatiangroup.com



SIGNAGE AND WAYFINDING
ENTRO
23 HARBOUR SQUARE, SUITE 202 TORONTO, ON M5J 2G2
TEL: (416) 368-6888 WEBSITE: entro.com

VIBRATION, NOISE, ACOUSTICS
SWALLOW ACOUSTICS CONSULTANTS LTD.
23-366 REVELS AVENUE MISSISSAUGA, ON L6G 4S5
TEL: (905) 271-8988 WEBSITE: thorntonmte85.com

BUILDING CODE
LRI ENGINEERING INC.
170 UNIVERSITY AVE. 3RD FLOOR, BOX 1 TORONTO, ON M5H 3B3
TEL: (416) 515-8551 WEBSITE: lri-ee.com

VERTICAL TRANSPORTATION
SOBERMAN ENGINEERING INC.
55 ST. CLAIR AVENUE WEST, SUITE 205 TORONTO, ON M5V 2T7
TEL: (416) 323-2133 WEBSITE: sobermanengineering.com

HARDWARE
SPYDERSC
35 HUDA RD. WOODBRIDGE, ON L4H 3M5
TEL: (847) 271-6489 WEBSITE: spydersc.com

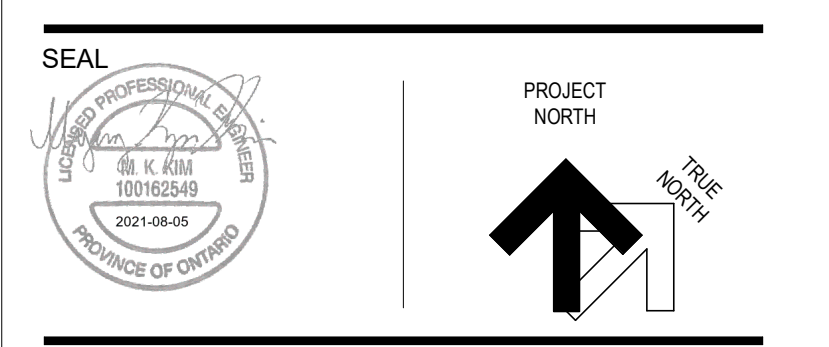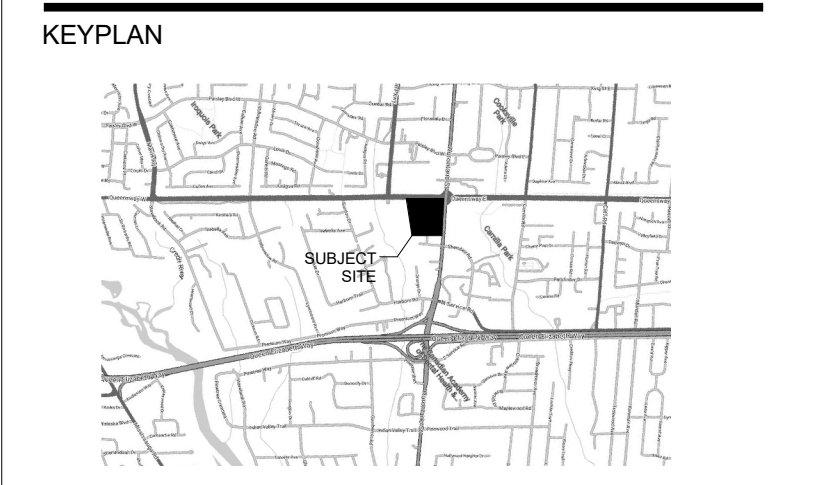

THP M-SITE HOSPITAL PARKING STRUCTURE

MISSISSAUGA HOSPITAL
100 QUEENSWAY WEST
MISSISSAUGA, ONTARIO
L5B 1B8

MECHANICAL SITE PLAN

DRAWN: Author CHECKED: Checker
PLOT DATE: 8/5/2021 8:44:31 PM

M0.02

C:\Revit\log
File\dwg_2003572_ME_THP_M_PARKING_GCA@dialogdesign.ca.rvt