



ISSUED FOR


1	2021-05-20	SCHEMATIC DESIGN
2	2021-06-25	CA 50%
3	2021-07-23	100% DESIGN DEVELOPMENT QA
4	2021-08-06	BID BP01
5	2021-08-06	BUILDING PERMIT
6	2021-08-06	SITE PLAN APPROVAL

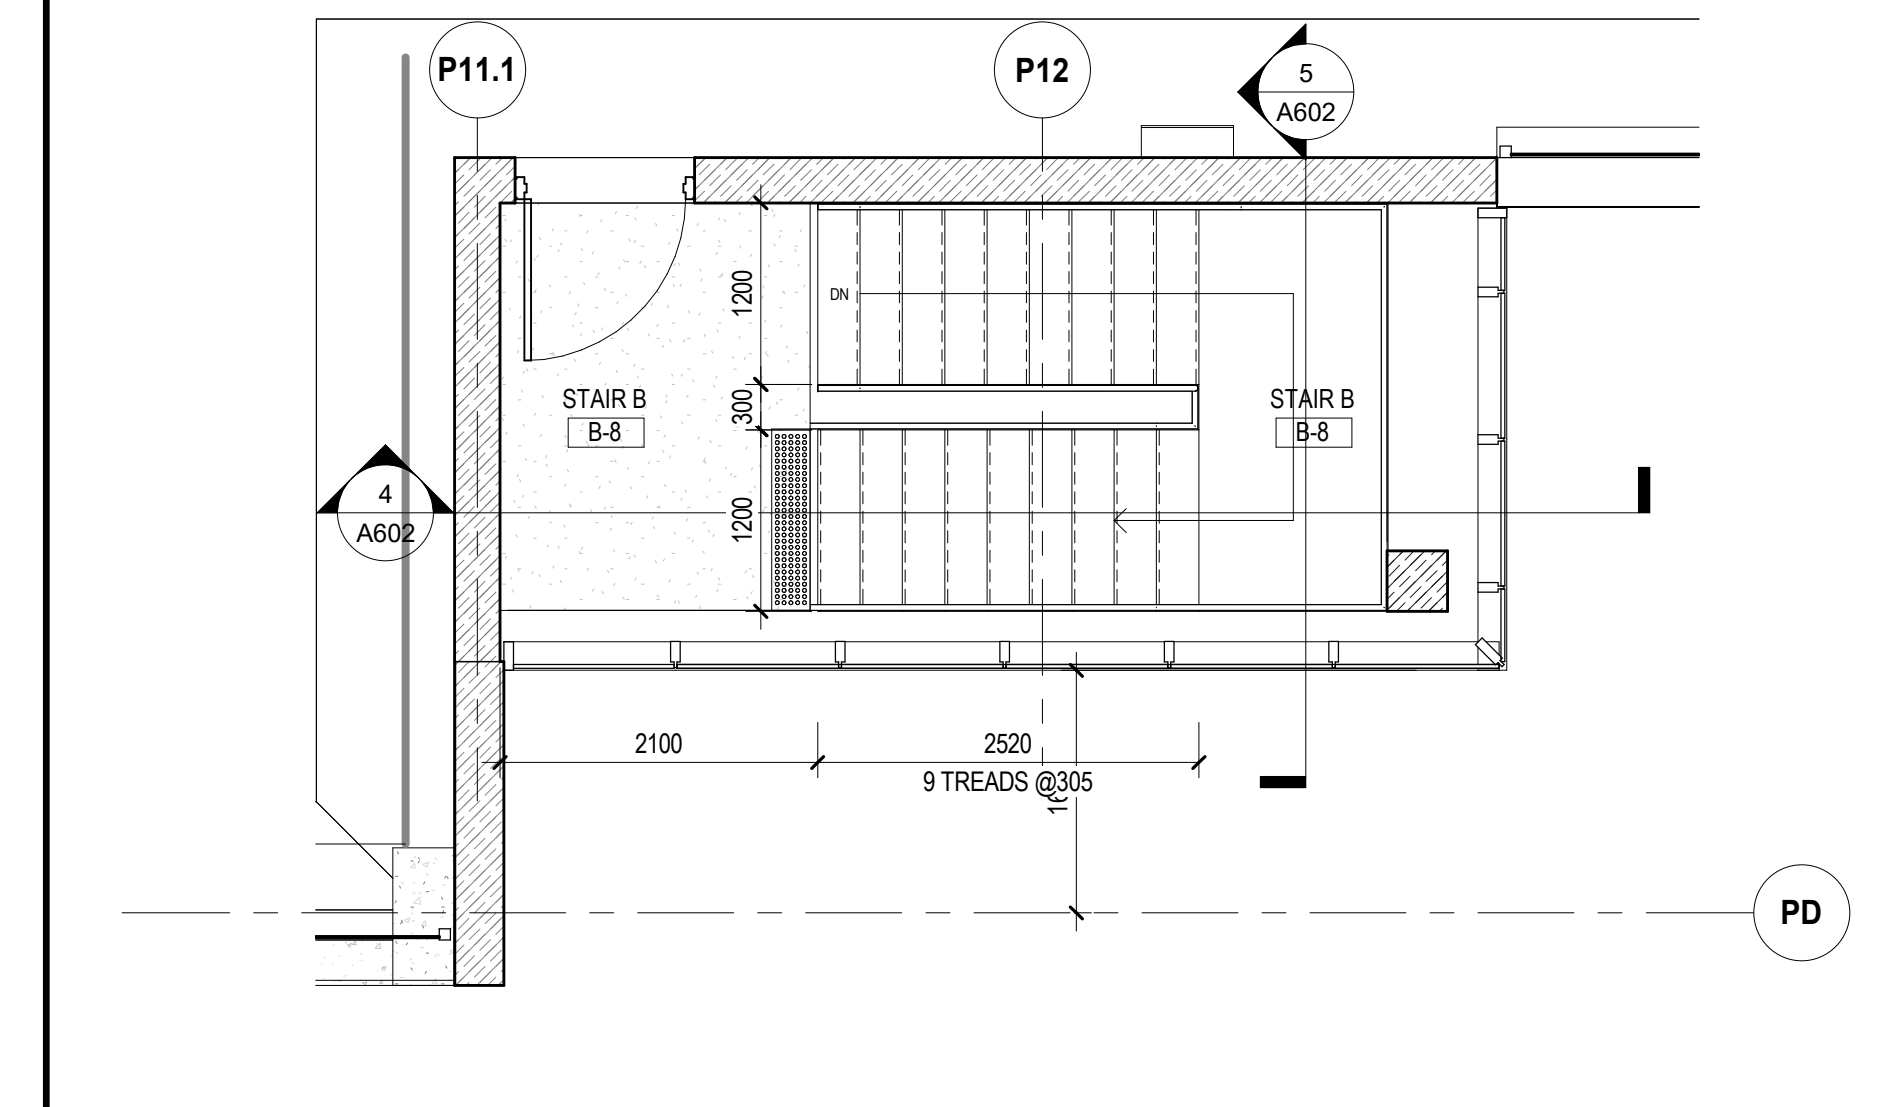


ENLARGED FLOOR PLAN - P8 - STAIR B
 SCALE: 1:50 A602

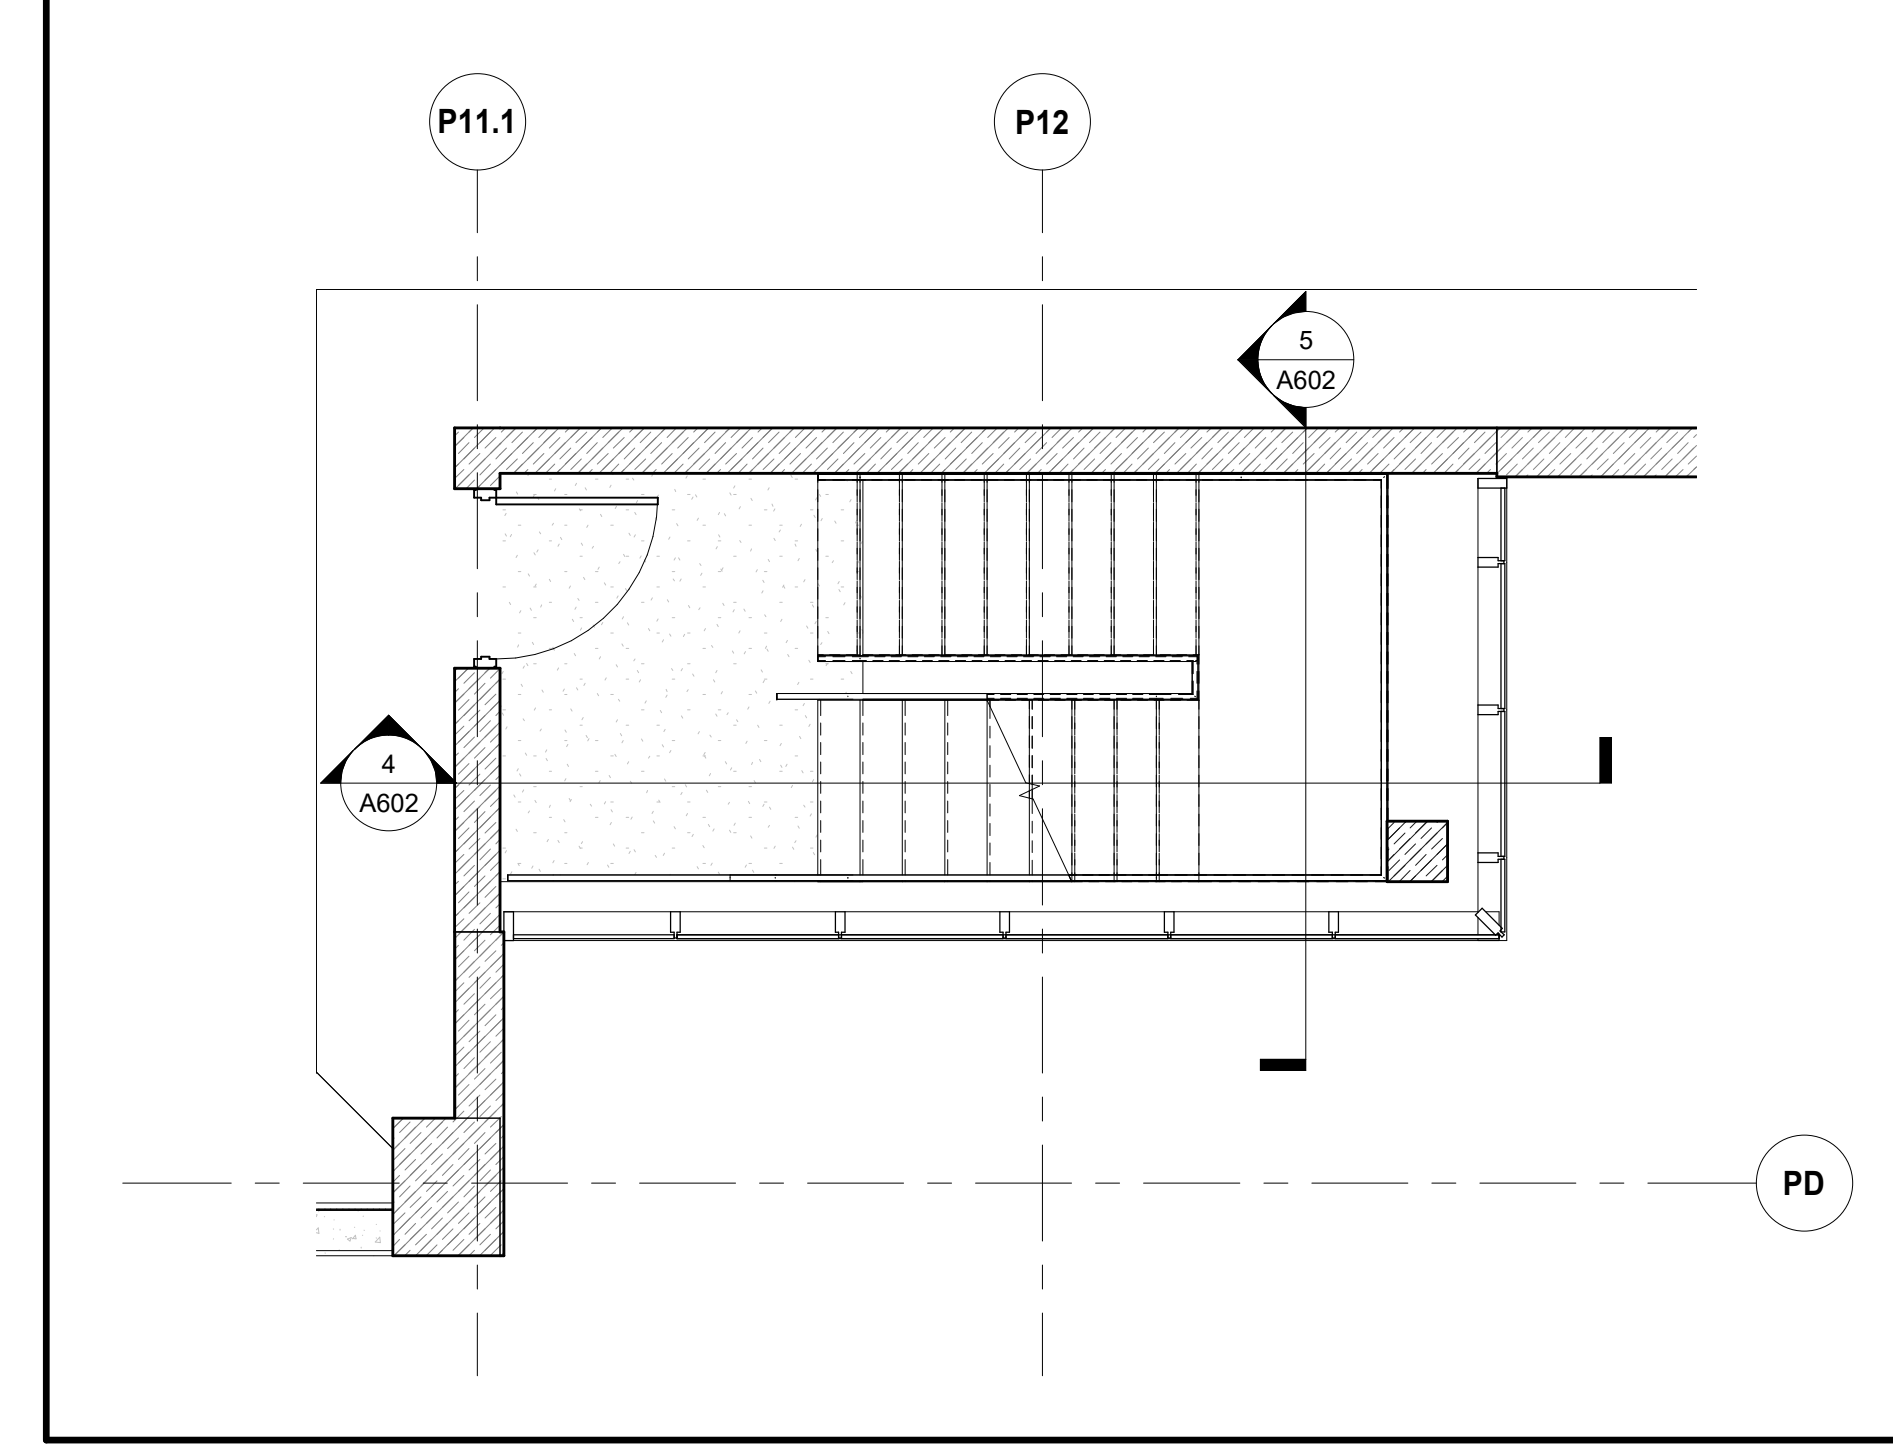


ENLARGED FLOOR PLAN - P4 & P7 - STAIR B
 SCALE: 1:50 A602

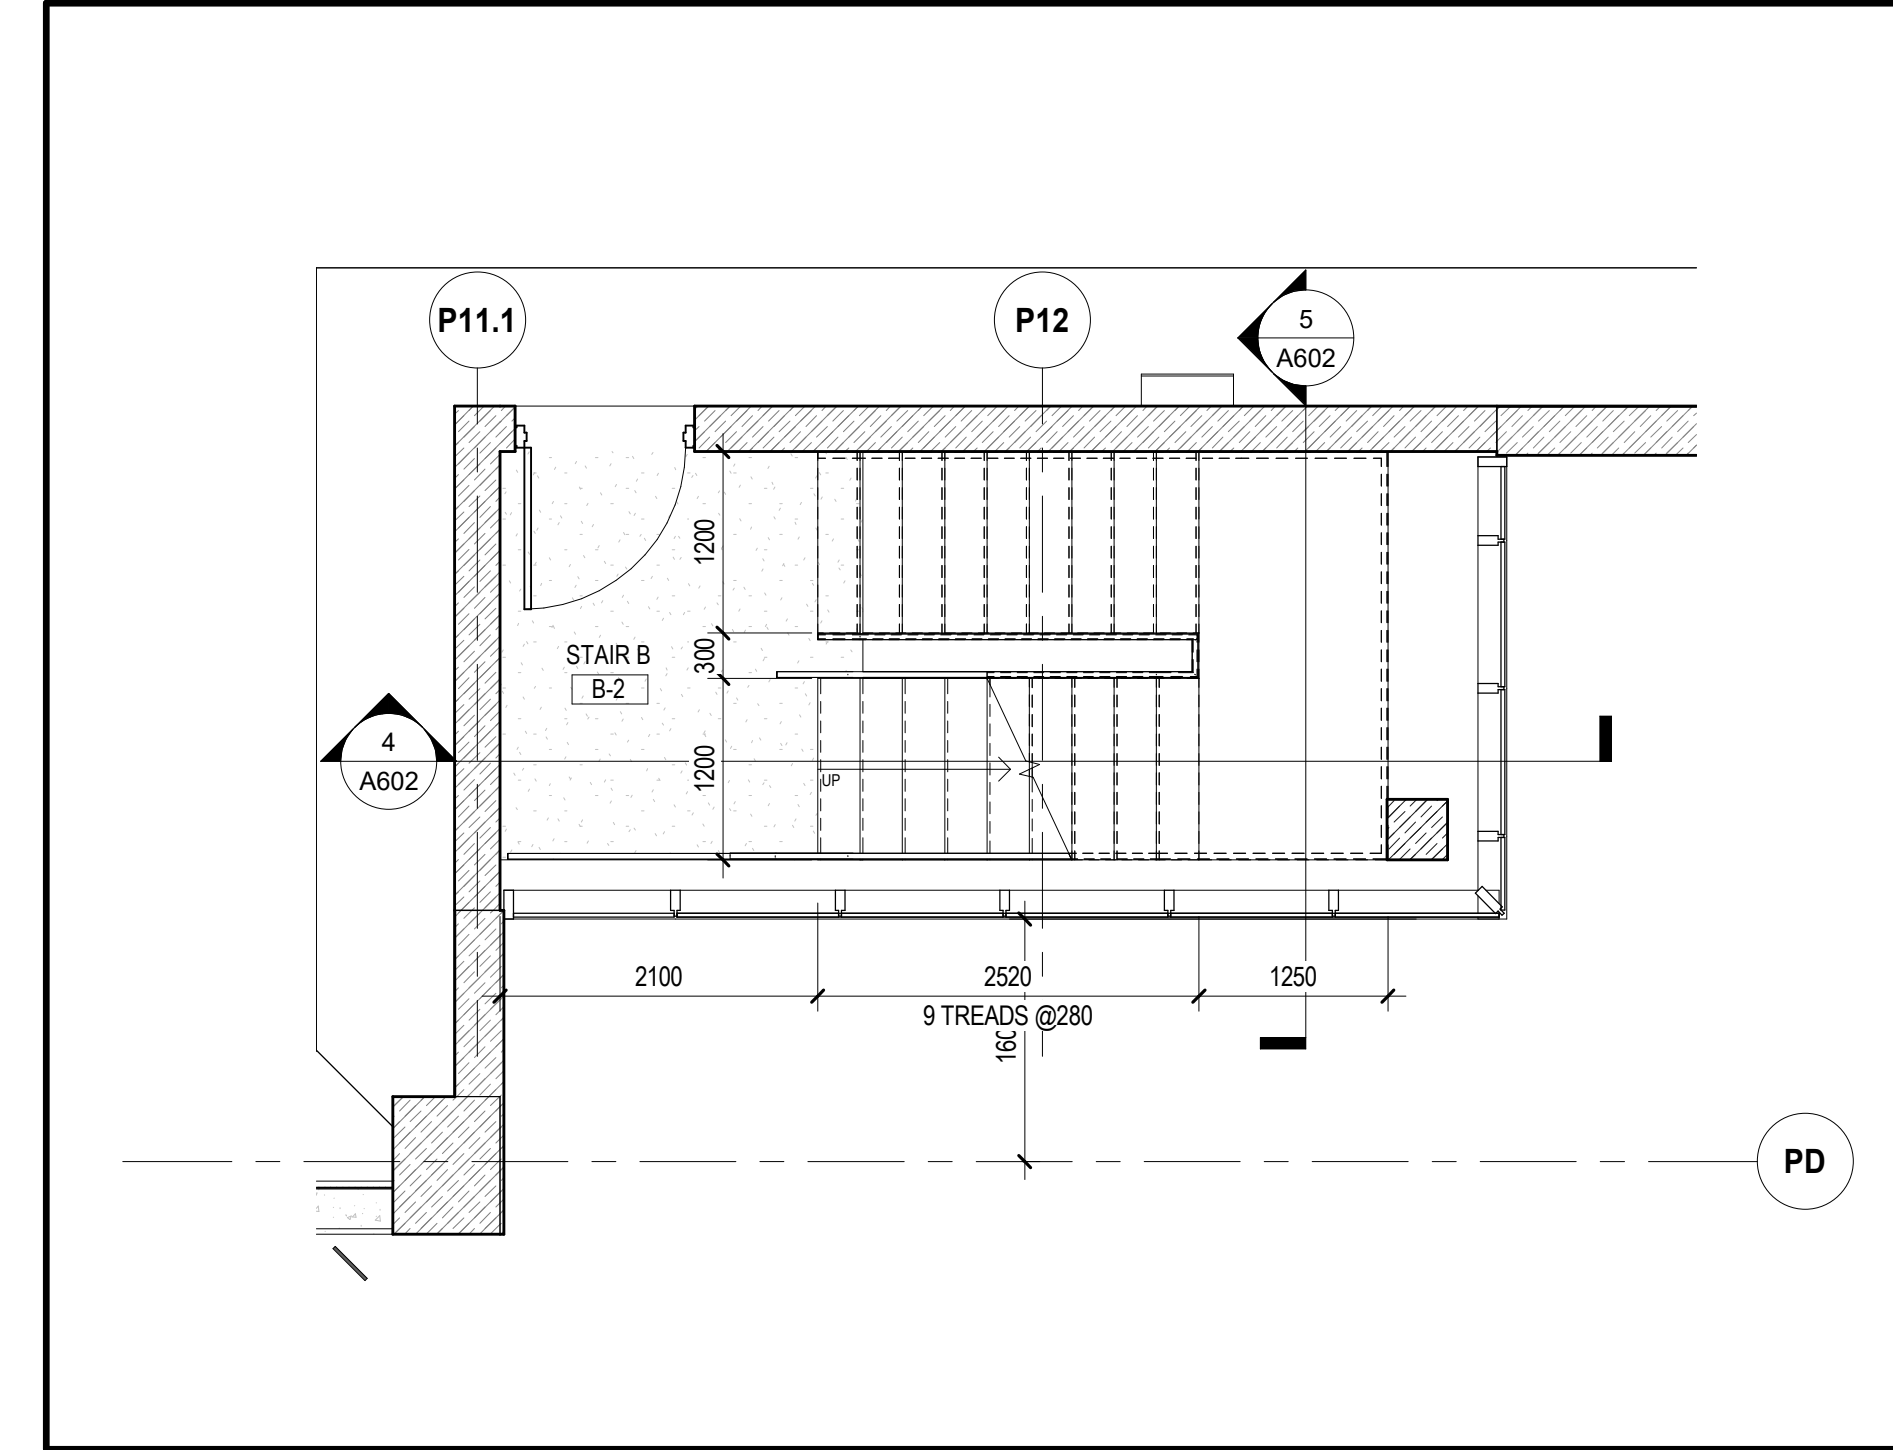


ENLARGED FLOOR PLAN - TYPICAL LEVEL - STAIR B
 SCALE: 1:50 A602

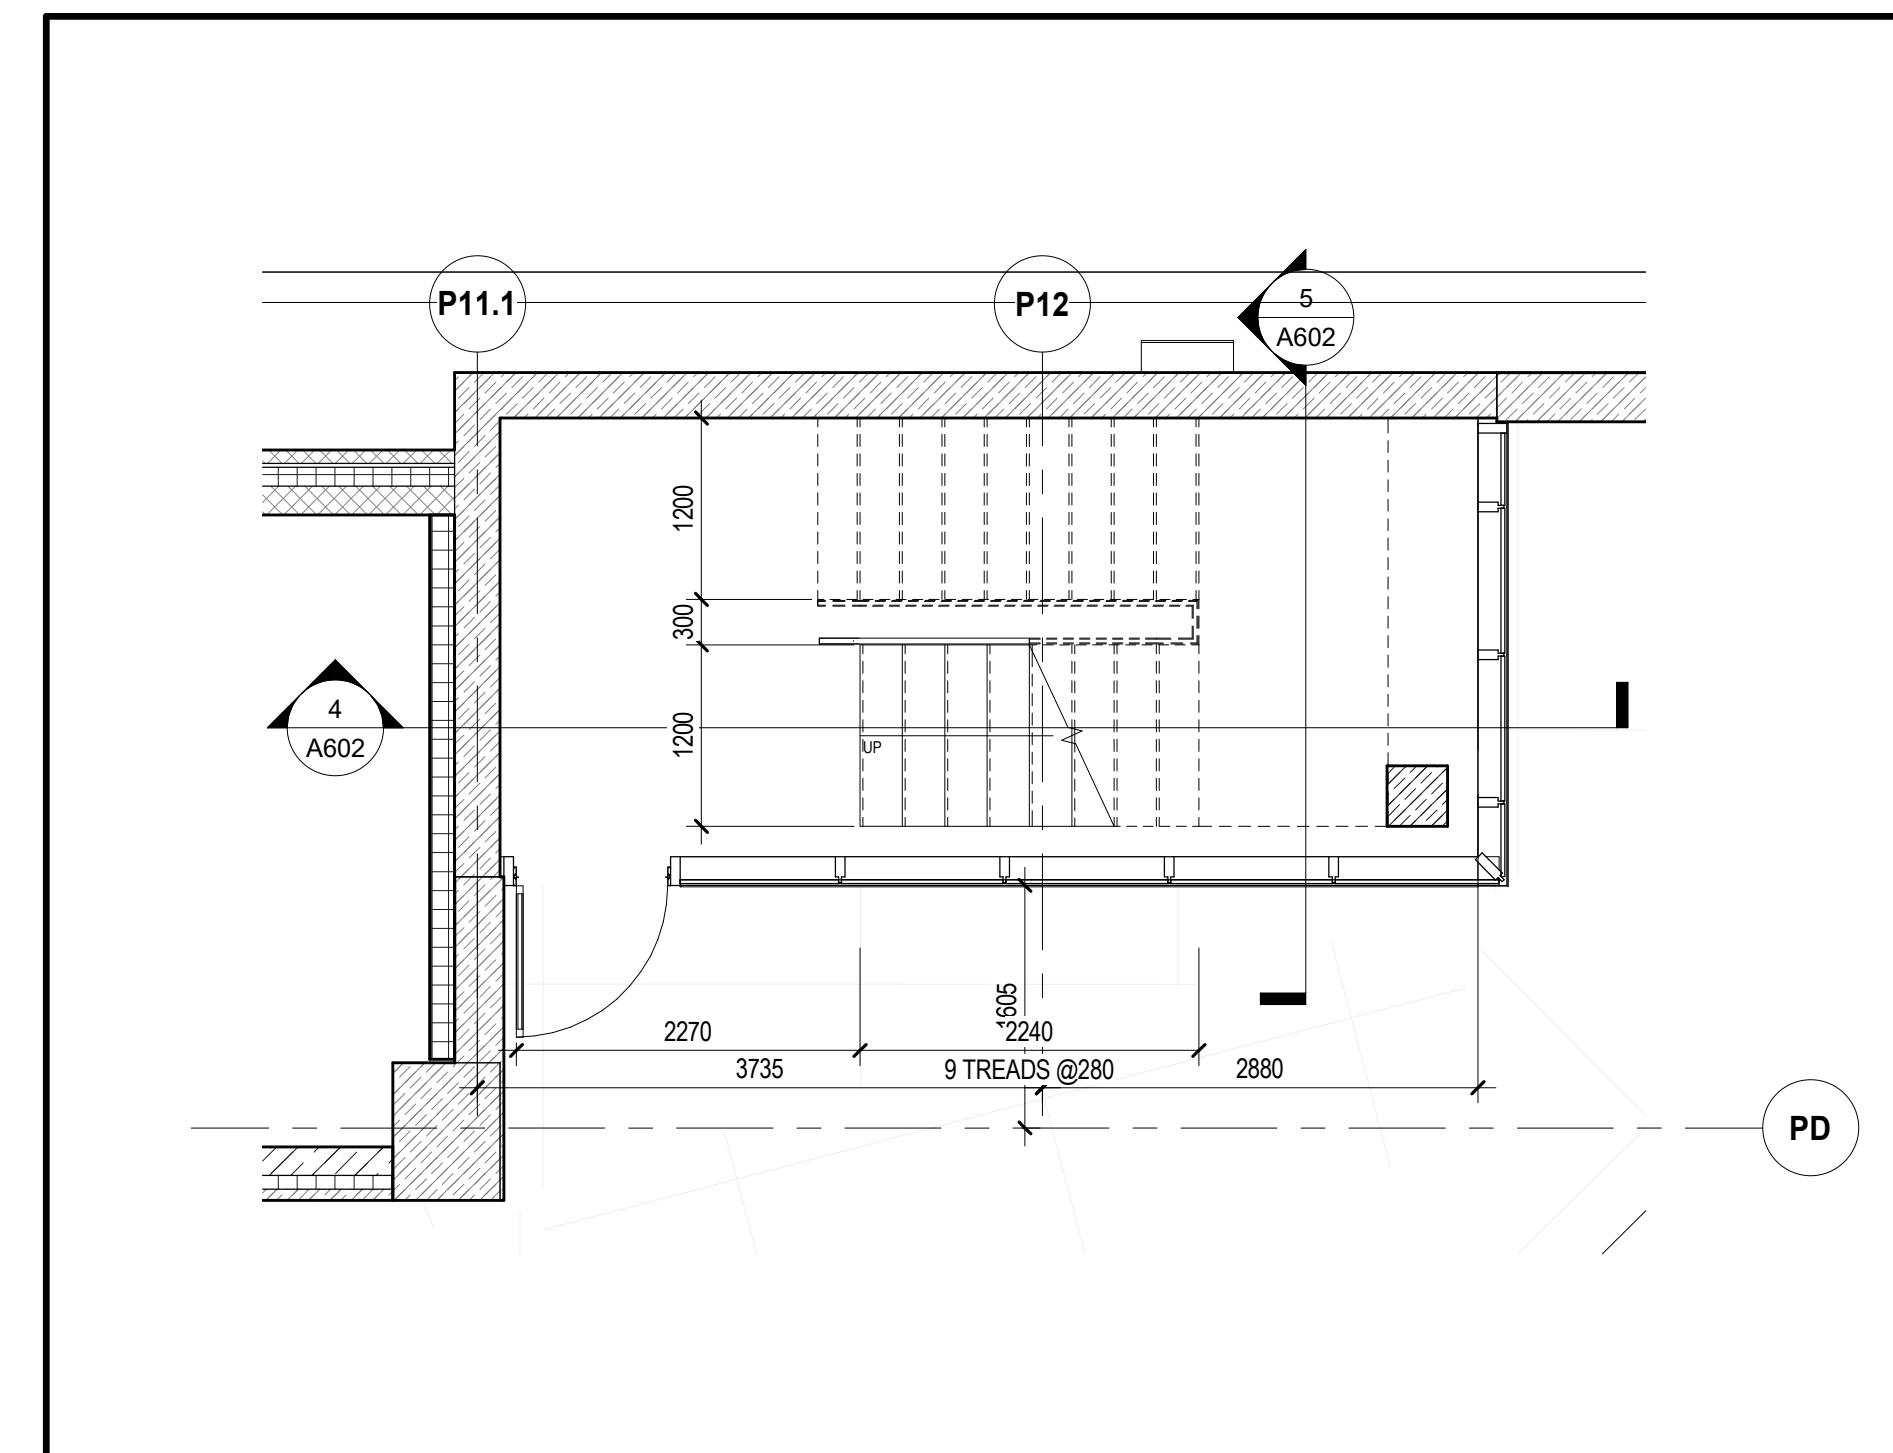

ENLARGED FLOOR PLAN - P1 - STAIR B
 SCALE: 1:50 A602

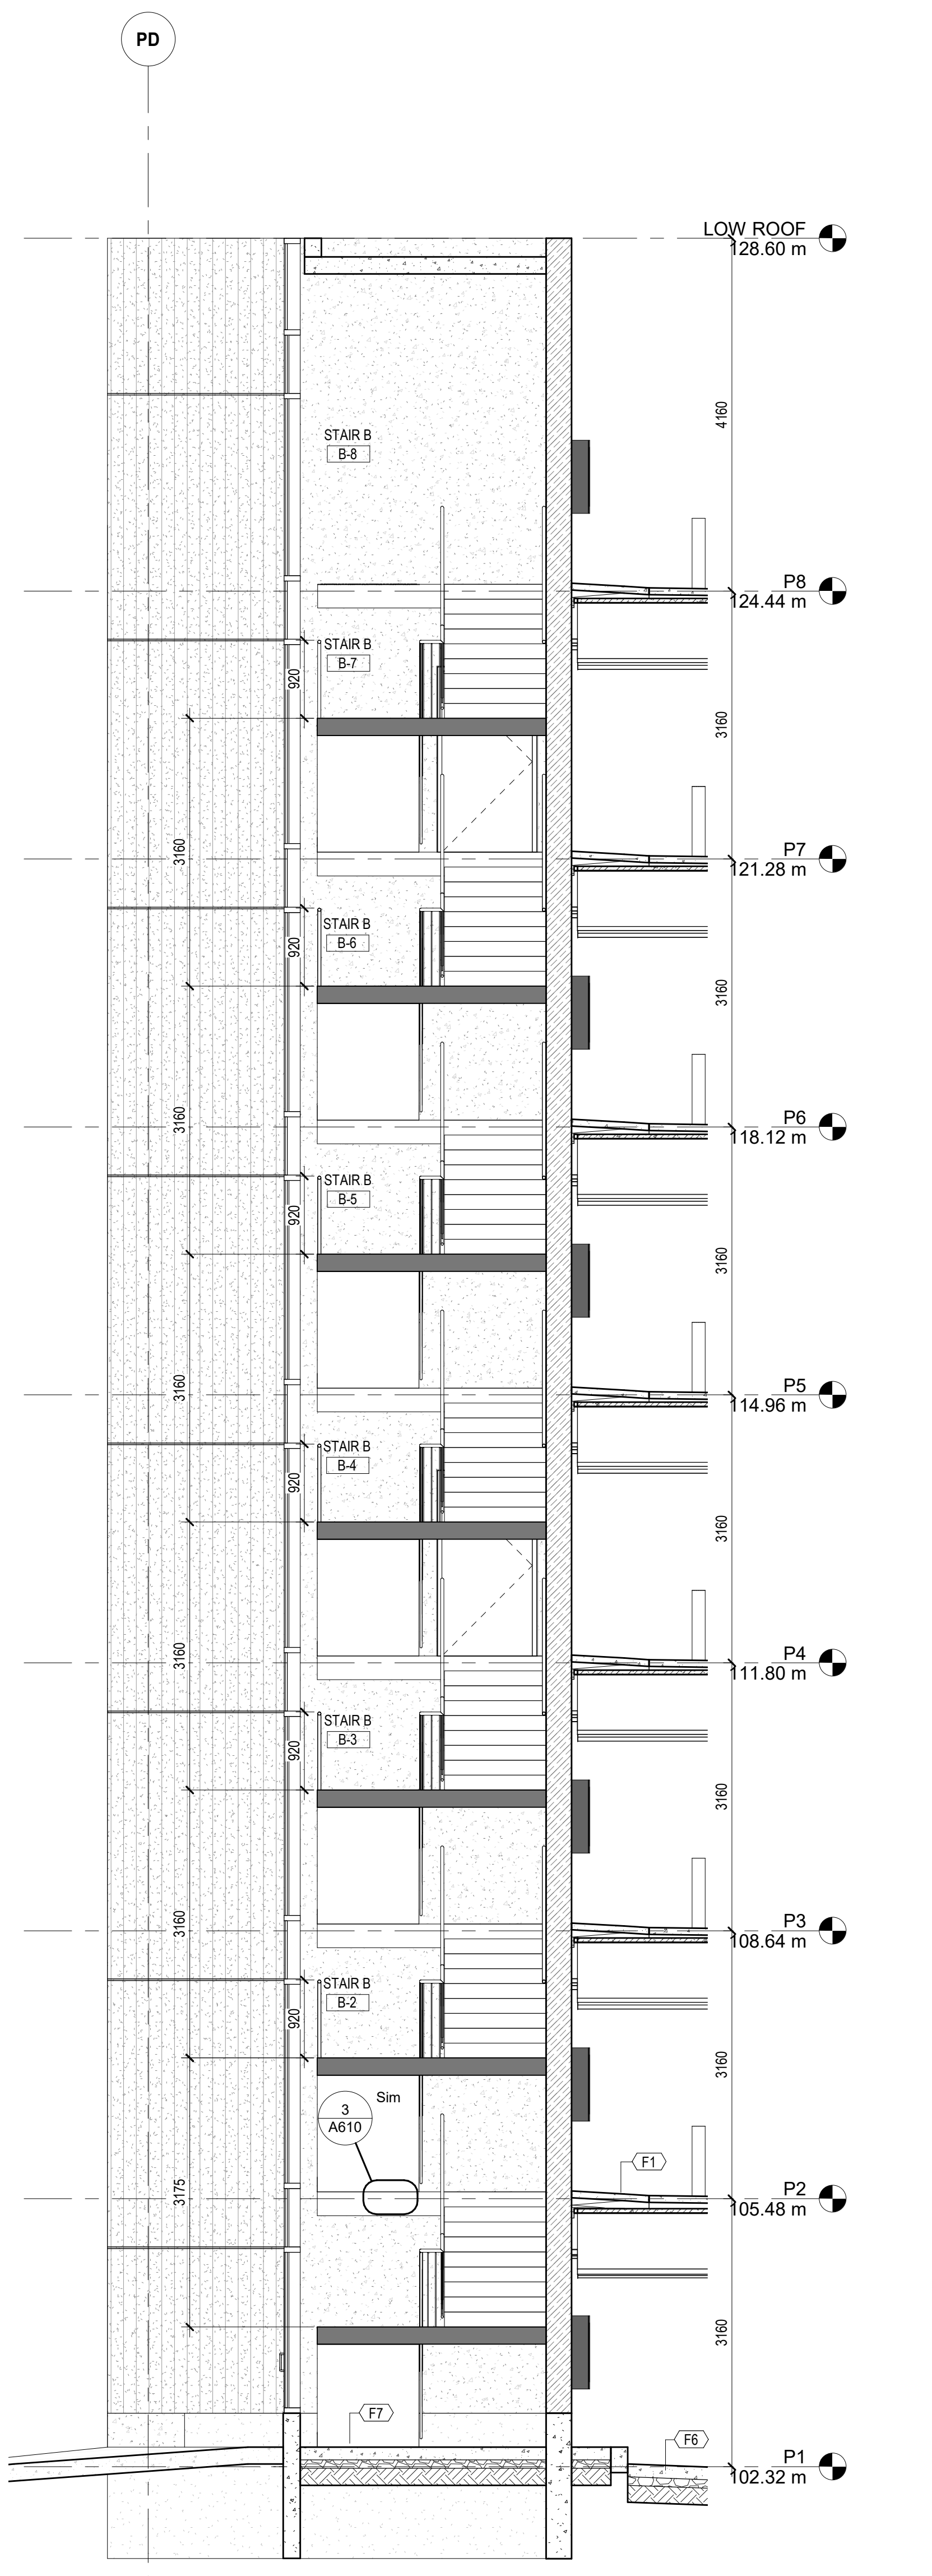

SECTION 2 - STAIR B
 SCALE: 1:50 A602

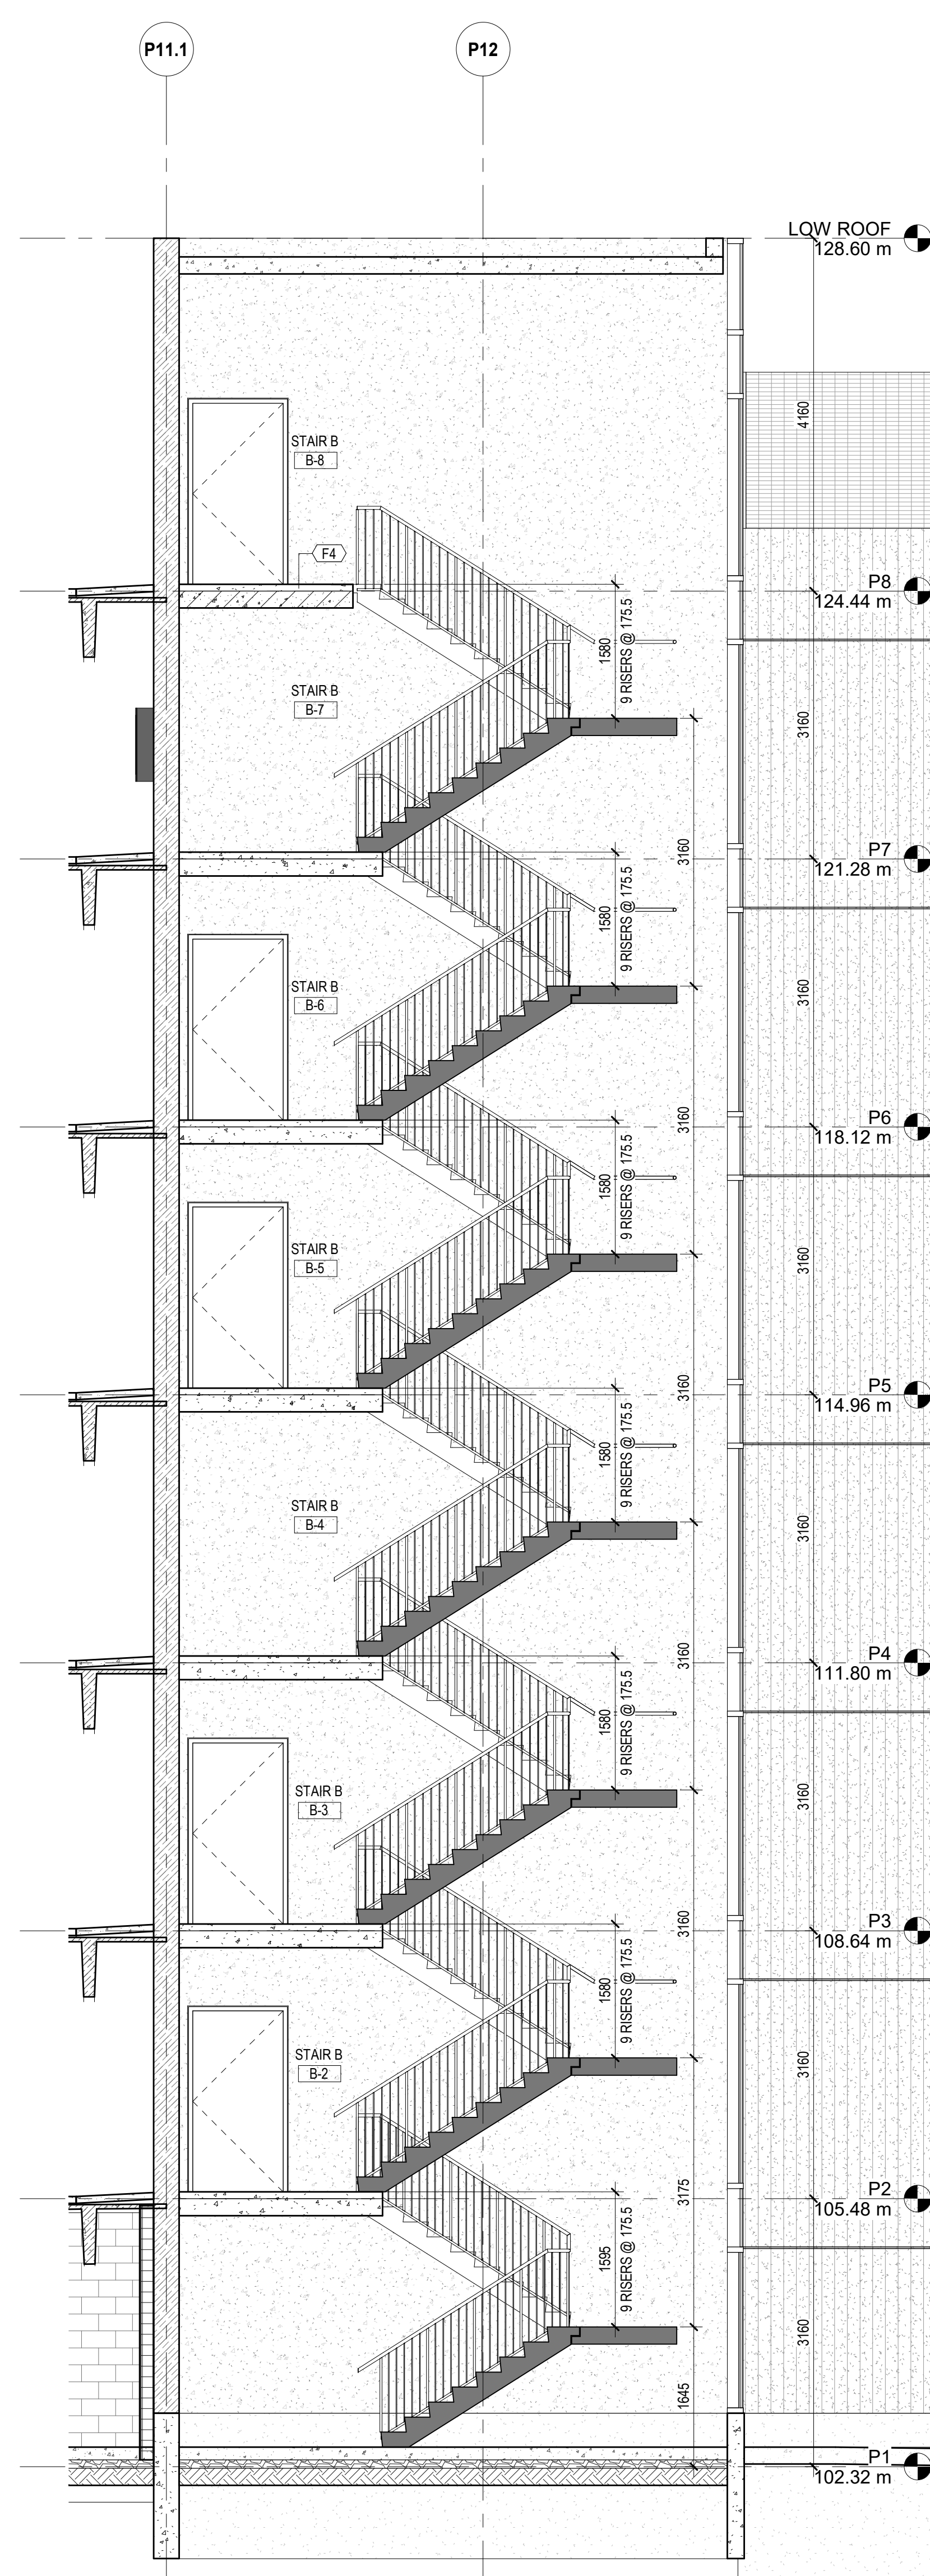

SECTION 1 - STAIR B
 SCALE: 1:50 A602

METRIC
 THIS DRAWING IS COPYRIGHTED AND MUST NOT BE USED, REPRODUCED, OR REVISED WITHOUT WRITTEN PERMISSION. VERIFY DIMENSIONS. DO NOT SCALE THIS DRAWING.
 REPORT INCONSISTENCIES AND OMISSIONS TO THE CONSULTANT FOR CLARIFICATION BEFORE COMMENCING WITH THE WORK. DEVIATIONS FROM THE CONTRACT DOCUMENTS WITHOUT WRITTEN APPROVAL FROM THE CONSULTANT ARE SUBJECT TO CORRECTION AT THE CONTRACTOR'S EXPENSE.

CLIENT
 TRILLIUM HEALTH PARTNERS
 150 BERRWAY DR. ETOBICOKE
 TORONTO, ON M9C 1A5
 TEL: (416) 291-8171 WEBSITE: trilliumhealthpartners.ca

CONSTRUCTION MANAGER
 KENADAN CONTRACTING LTD.
 7180 BERRYBROOK DRIVE
 MISSISSAUGA, ON L5N 0G5
 TEL: (905) 910-2680 WEBSITE: www.kenadan.com/

ARCHITECT & PRIME CONSULTANT
 DIALOG
 35 JOHN STREET, SUITE 500
 TORONTO, ON M5V 2G8
 TEL: (416) 966-0220 WEBSITE: dialogdesign.ca

STRUCTURAL ENGINEER
 DIALOG

MECHANICAL ENGINEER
 DIALOG

ELECTRICAL ENGINEER
 DIALOG

LANDSCAPE ARCHITECT
 DIALOG

CIVIL ENGINEER
 MTE CONSULTANTS INC.
 1018 SUTTON DRIVE, UNIT A
 BURLINGTON, ON L7R 1B8
 TEL: (905) 639-2322 WEBSITE: mte85.com

SECURITY
 THE ATARIAN GROUP INC.
 28-180 WOODWARD DRIVE
 OTTAWA, ON K2C 3P7
 TEL: (613) 817-5998 WEBSITE: theatargroup.com

SIGNAGE AND WAYFINDING
 ENTRIO
 13 HARBOUR SQUARE, SUITE 202
 TORONTO, ON M5J 2G2
 TEL: (416) 368-6888 WEBSITE: entrio.com


VIBRATION, NOISE, ACOUSTICS
 SWALLOW ACOUSTICS CONSULTANTS LTD.
 23 366 REVELS AVENUE
 MISSISSAUGA, ON L5G 4S5
 TEL: (905) 271-7858 WEBSITE: throntonswallow.com

BUILDING CODE
 LRI ENGINEERING INC.
 171 UNIVERSITY AVE. 3RD FLOOR, BOX 1
 TORONTO, ON M5H 1B3
 TEL: (416) 515-9331 WEBSITE: lrinfo.com

VERTICAL TRANSPORTATION
 SIEBEMAN ENGINEERING INC.
 55 ST. CLAIR AVENUE WEST, SUITE 205
 TORONTO, ON M5V 1Y7
 TEL: (416) 323-1333 WEBSITE: siebemanengineering.com

HARDWARE
 SPYDER SC
 35 HILDA RD.
 WOODBRIDGE, ON L4H 3M5
 TEL: (847) 271-6489 WEBSITE: spyder-sc.com

KEYPLAN

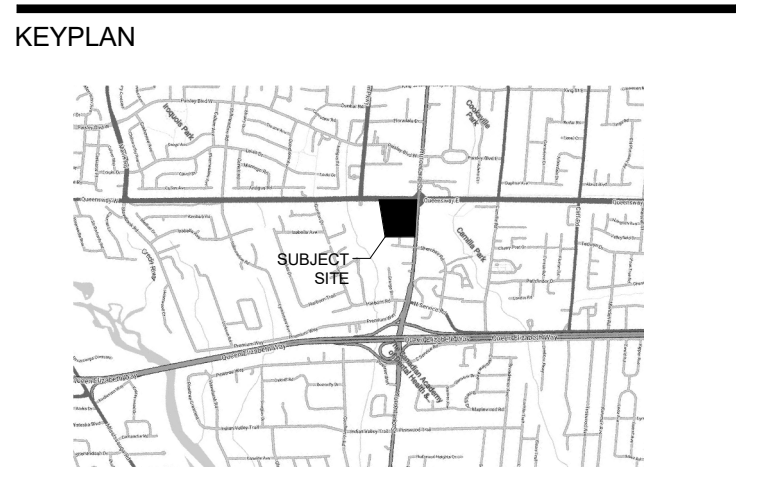

SEAL

**THP M-SITE HOSPITAL
 PARKING STRUCTURE**

MISSISSAUGA HOSPITAL
 100 QUEENSWAY WEST
 MISSISSAUGA, ONTARIO
 L5B 1B8

STAIR B

DRAWN: Author CHECKED: Checker
 PLOT DATE: 8/6/2021 11:29:27 AM