
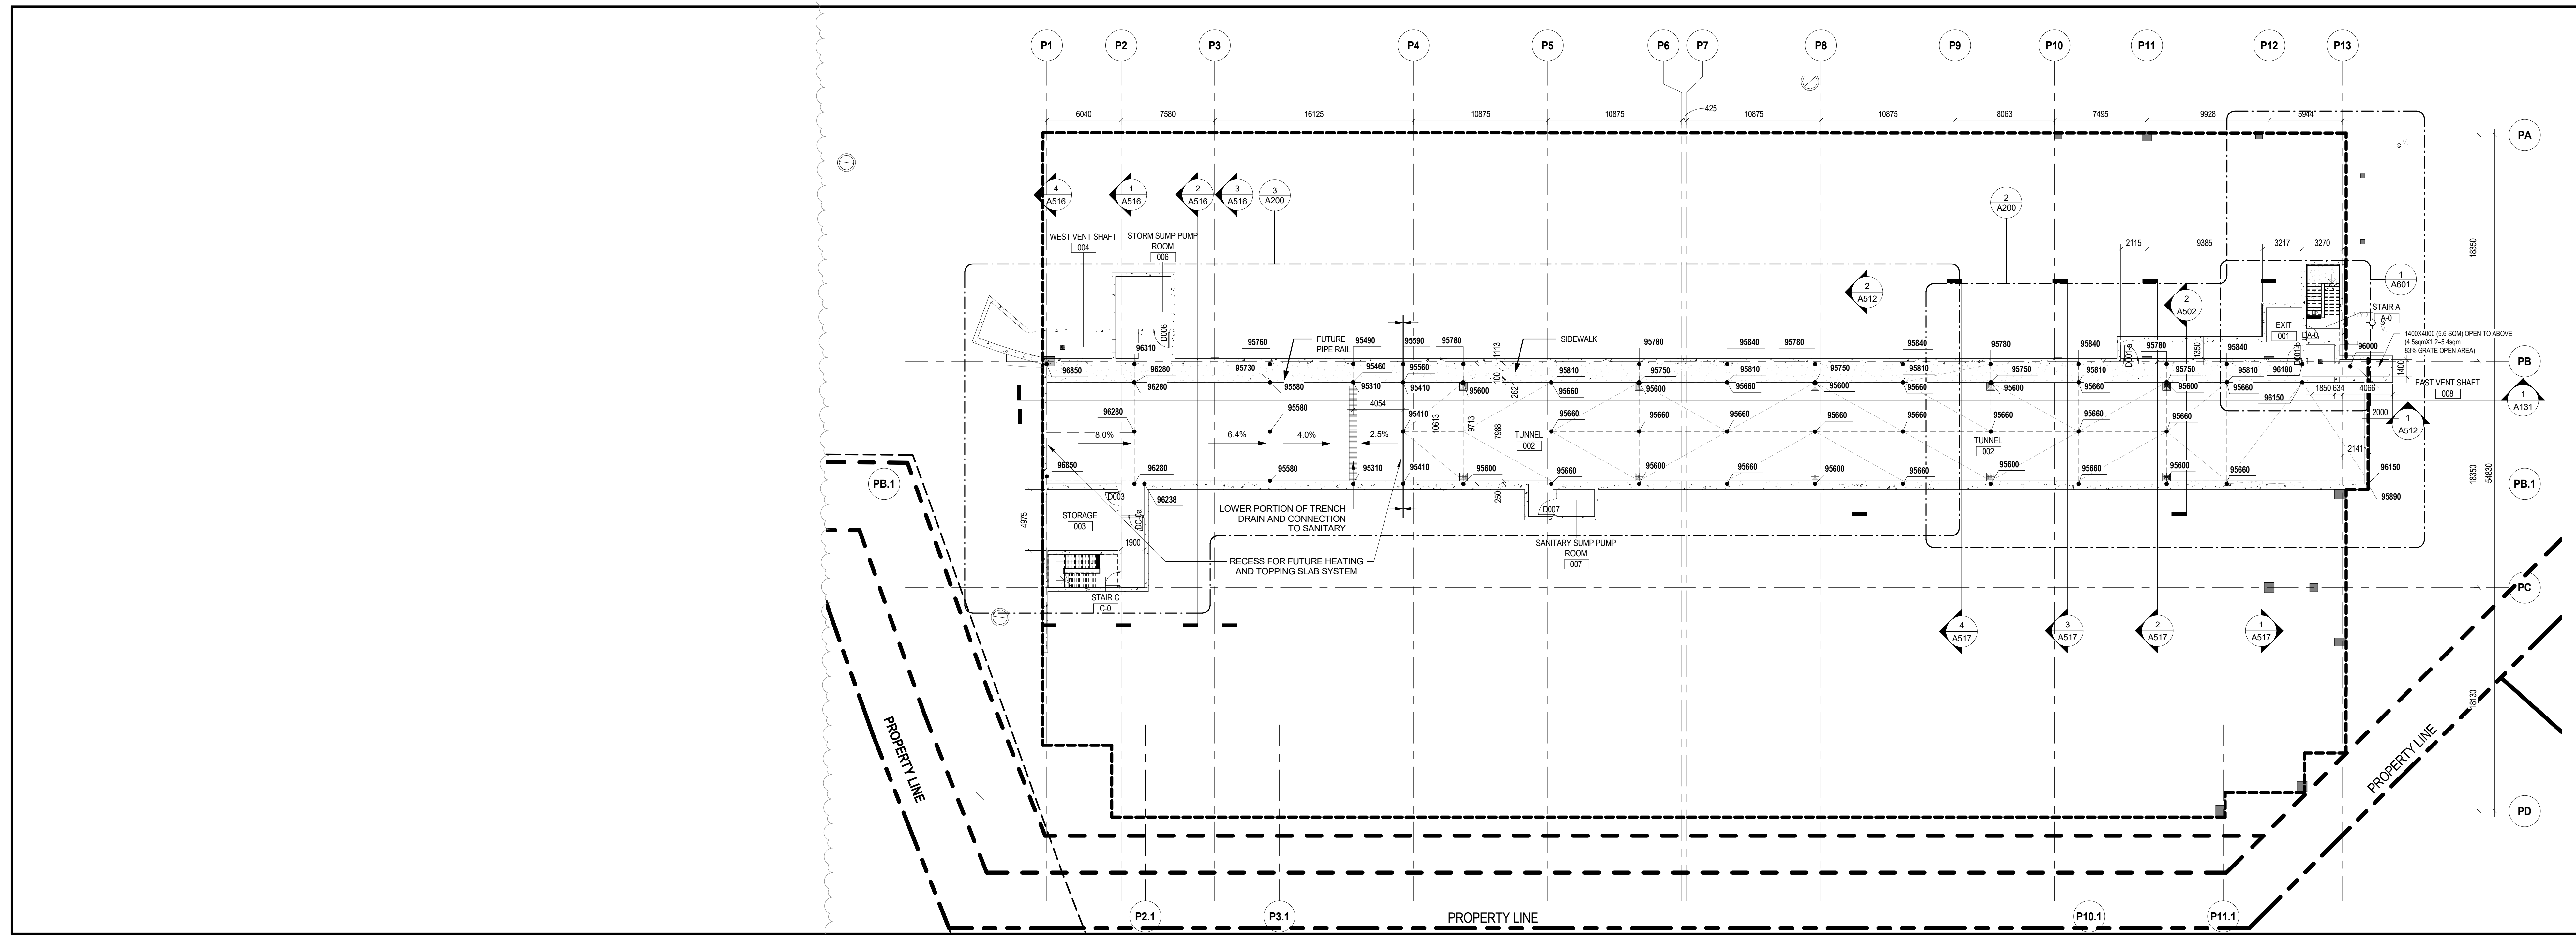


GENERAL NOTE
 PROVIDE PERIMETER DRAINAGE SYSTEM AT TUNNEL LEVEL.
 REFER TO DRAWINGS, SPECIFICATIONS, GEOTECHNICAL AND
 HYDROLOGICAL REPORTS

— DRAINAGE LINES

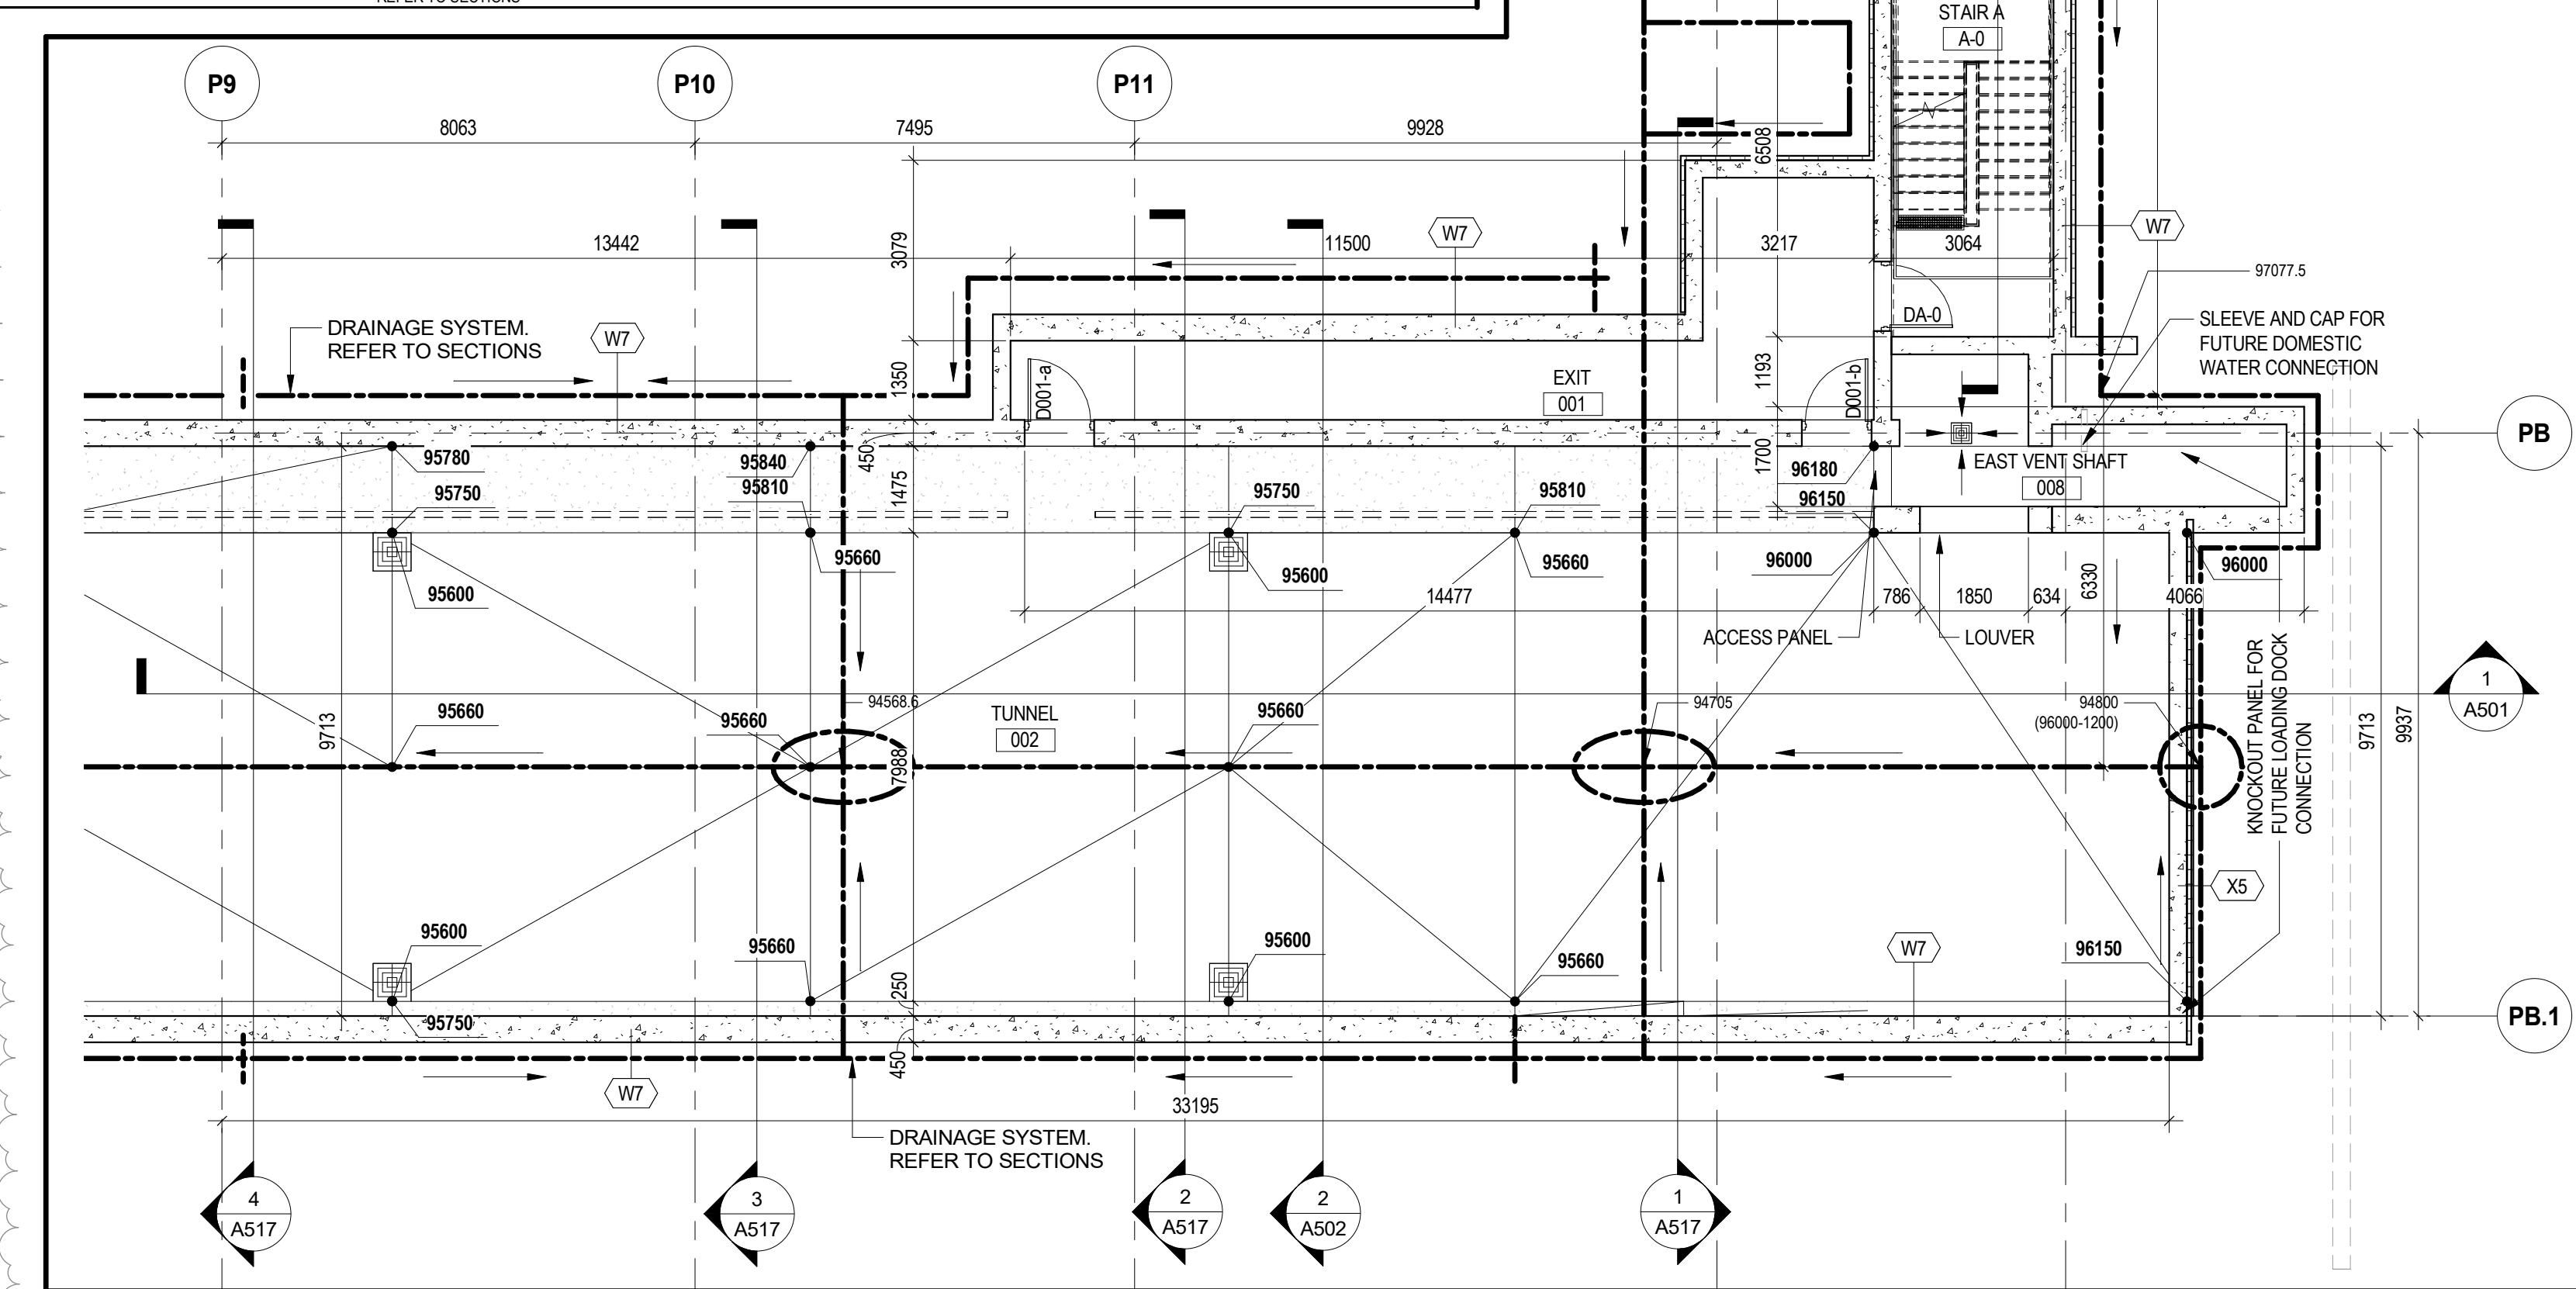

0m 4m 8m 12m 16m 20m
 SCALE 1:200

FLOOR PLAN - TUNNEL
 SCALE 1:200



- ISSUED FOR
- 1 2021-05-20 SCHEMATIC DESIGN
 - 2 2021-06-25 QA 50%
 - 3 2021-07-23 100% DESIGN DEVELOPMENT QA
 - 4 2021-08-06 BID BP01
 - 5 2021-08-06 BUILDING PERMIT
 - 6 2021-08-06 SITE PLAN APPROVAL
 - 7 2021-08-18 MOH 3.2
 - 8 2021-09-09 BID BP01 ADDENDUM NO. 2
 - 9 2021-09-15 BID BP01 ADDENDUM NO. 3
 - 10 2021-10-26 BP02 50% QA
 - 11 2021-10-29 MOH Stage 4.1
 - 12 2021-11-17 BP01 ADDENDUM NO. 8
 - 13 2021-11-18 BID BP01 ADDENDUM NO. 8
 - 14 2021-12-03 BP02 100% QA
 - 15 2021-12-06 BUILDING PERMIT RESUBMIT 1
 - 16 2021-12-17 BID BP02
 - 17 2022-02-24 BP01 - FUTURE ADDENDUM ITEM
 - 18 2022-02-24 SP 21-156 W7 REVISION 1

METRIC
 THIS DRAWING IS COPYRIGHTED AND MUST NOT BE USED,
 REPRODUCED, OR REVISED WITHOUT WRITTEN PERMISSION.
 ALL DIMENSIONS ARE IN MILLIMETERS UNLESS OTHERWISE NOTED.
 VERIFY DIMENSIONS.
 DO NOT SCALE THIS DRAWING.

REPORT INCONSISTENCIES AND OMISSIONS TO THE CONSULTANT
 FOR CLARIFICATION BEFORE COMMENCING WITH THE WORK.
 DEVIATIONS FROM THE CONTRACT DOCUMENTS WITHOUT WRITTEN
 APPROVAL FROM THE CONSULTANT ARE SUBJECT TO CORRECTION
 AT THE CONTRACTOR'S EXPENSE.

CLIENT
 TRILLIUM HEALTH PARTNERS
 150 DERRWAY DR. ETOBICOKE
 TORONTO, ON M9C 1A5
 TEL: (416) 299-8171 WEBSITE: trilliumhealthpartners.ca

CONSTRUCTION MANAGER
 KENADAN CONTRACTING LTD.
 780 BERRYPREST DRIVE
 MISSISSAUGA, ON L5N 0G5
 TEL: (905) 910-2660 WEBSITE: www.kenadan.com/

ARCHITECT & PRIME CONSULTANT
 DIALOG
 35 JOHN STREET, SUITE 500
 TORONTO, ON M5V 2S8
 TEL: (416) 966-0229 WEBSITE: dialogdesign.ca

STRUCTURAL ENGINEER
 DIALOG

MECHANICAL ENGINEER
 DIALOG

ELECTRICAL ENGINEER
 DIALOG

LANDSCAPE ARCHITECT
 DIALOG

CIVIL ENGINEER
 MTE CONSULTANTS INC.
 1018 SUTTON DRIVE, UNIT A
 BURLINGTON, ON L7R 1B8
 TEL: (905) 638-2322 WEBSITE: mte85.com

SECURITY
 THE ATARIAN GROUP INC.
 288-180 WOODWARD DRIVE
 OTTAWA, ON K1H 8K9
 TEL: (613) 817-2929 WEBSITE: theatariangroup.com


SIGNAGE AND WAYFINDING
 ENTRO
 33 HARBOUR SQUARE, SUITE 202
 TORONTO, ON M5J 2G2
 TEL: (416) 368-6868 WEBSITE: entro.com

VIBRATION, NOISE, ACOUSTICS
 THORNTON/MASETTI
 23366 REVELS AVENUE
 MISSISSAUGA, ON L5G 4S5
 TEL: (905) 271-1859 WEBSITE: throntonmasetti.com

BUILDING CODE
 LRI ENGINEERING INC.
 171 UNIVERSITY AVE. 3RD FLOOR, BOX 1
 TORONTO, ON M5H 1B3
 TEL: (416) 515-9331 WEBSITE: lriinc.com

VERTICAL TRANSPORTATION
 SOBEMAN ENGINEERING INC.
 55 ST. CLAIR AVENUE WEST, SUITE 205
 TORONTO, ON M5V 1Y7
 TEL: (416) 323-2133 WEBSITE: sobemanengineering.com

HARDWARE
 SPYDER
 35 HILDA RD
 WOODBRIDGE, ON L4H 3M5
 TEL: (947) 271-6459 WEBSITE: spyderinc.com

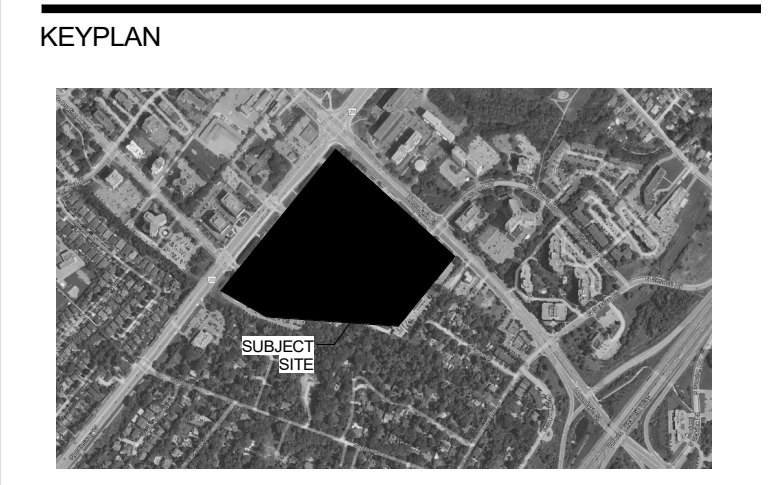

**THP M-SITE HOSPITAL
 PARKING STRUCTURE**

MISSISSAUGA HOSPITAL
 100 QUEENSWAY WEST
 MISSISSAUGA, ONTARIO
 L5B 1B8

TUNNEL PLAN

DRAWN: Author CHECKED: Checker
 PLOT DATE: 31/12/2022 4:18:59 PM

A200